

Notice of Waterline Construction

Please be advised that Travis County WCID 10 has commenced work on a waterline installation project near your home. The purpose of the project is for maintenance of District infrastructure and upgrading of the waterline size resulting in greater capacity and function.

During the construction, traffic control measures will be taken to help assist residents through the construction area. The contractor will be as considerate as possible while working in your neighborhood. Please understand that as with any construction zone, residents should expect noise and dirt in the area the crews are working. The work area will be cleaned at the end of the work day. At this time work hours are Monday – Friday from 7am-3:30pm.

Project Details:

Contractor:

Prota Construction
Juan Caseres
jcaeres@protaconstruction.com

Contract time:

180 days

Comments or Concerns:

Travis County WCID 10
Carla Glass
Generalmanager@waterdistrict10.org
(512) 327-2230

What can you expect?


- Installation of silt fencing along the road for erosion control
- Scoring on the road marking layout of waterline
- Trenching and waterline installation
- Flowable fill to trench
- Temporary cold patch directly over trench to allow smooth driving surface

Once waterline has been installed along the entire project:

- Mill and overlay of the road (paving)
- Clean up along the project
- Re-vegetation of all affected areas
- Removal of erosion controls

Customer will be notified 48 hours in advance in the event of any infrequent disruption to daily routine.

This project has been phased. **ONLY Phase 1 is underway**, Phase 2 is in design. Please see the map on the backside of this page for location detail.

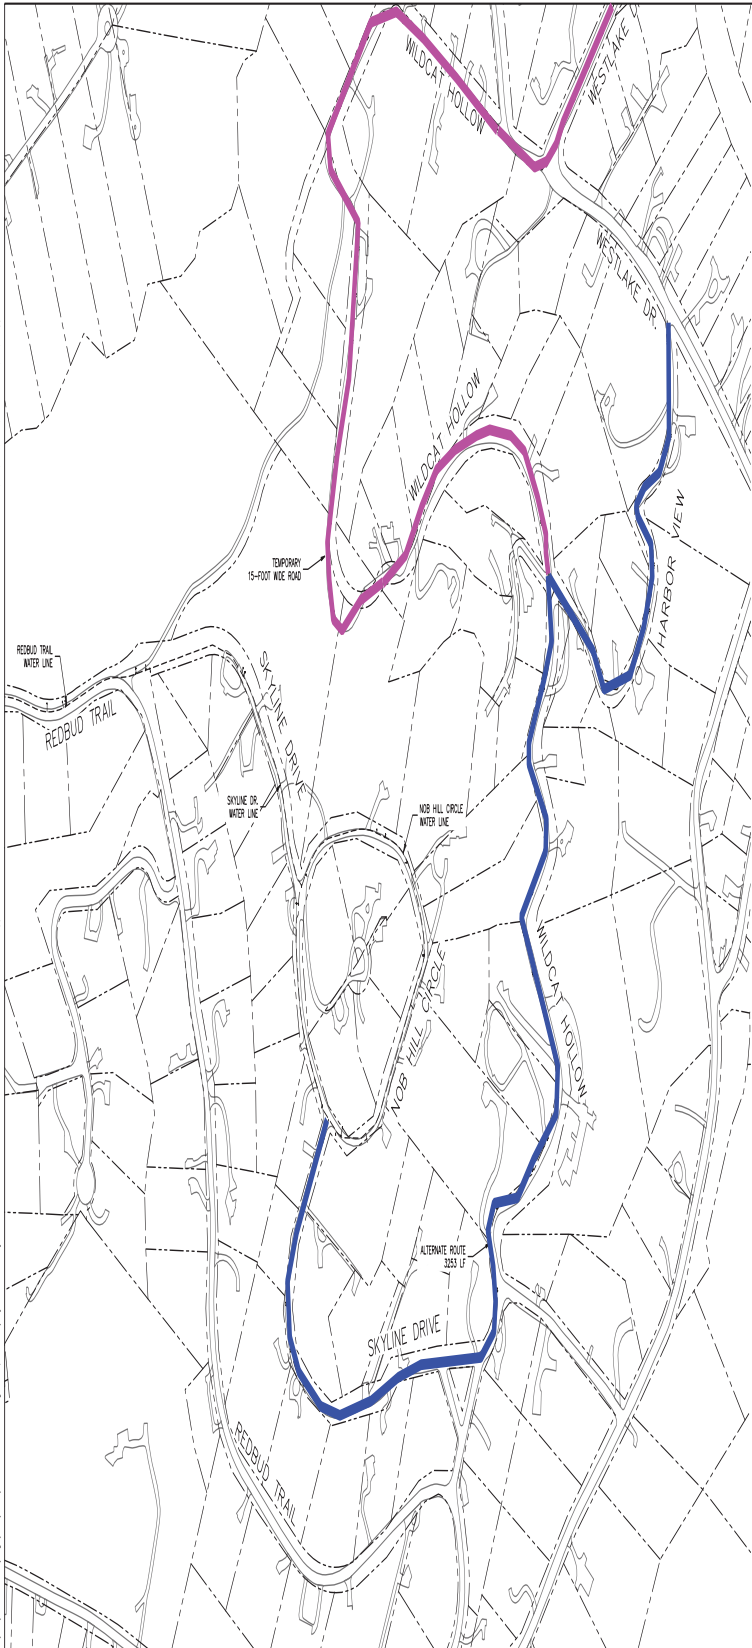

DANNENBAUM
 1000 WEST LAKE DRIVE, SUITE 100, FORT COLLINS, CO 80504
 TEL: 970.226.1100 FAX: 970.226.1101

WATER LINE ALTERNATE ROUTE

THIS PLAN IS A PRELIMINARY DESIGN AND IS SUBJECT TO CHANGE WITHOUT NOTICE. IT IS NOT TO BE USED FOR CONSTRUCTION OR AS A BASIS FOR OBTAINING PERMITS.

REVISIONS

NO.	DATE	DESCRIPTION

SHEET NO.
1 OF 1
 DEC. JOB NUMBER
7009-44